


**A**  
C-3  
ENLARGED SITE PLAN  
SCALE: 3/16" = 1'-0"

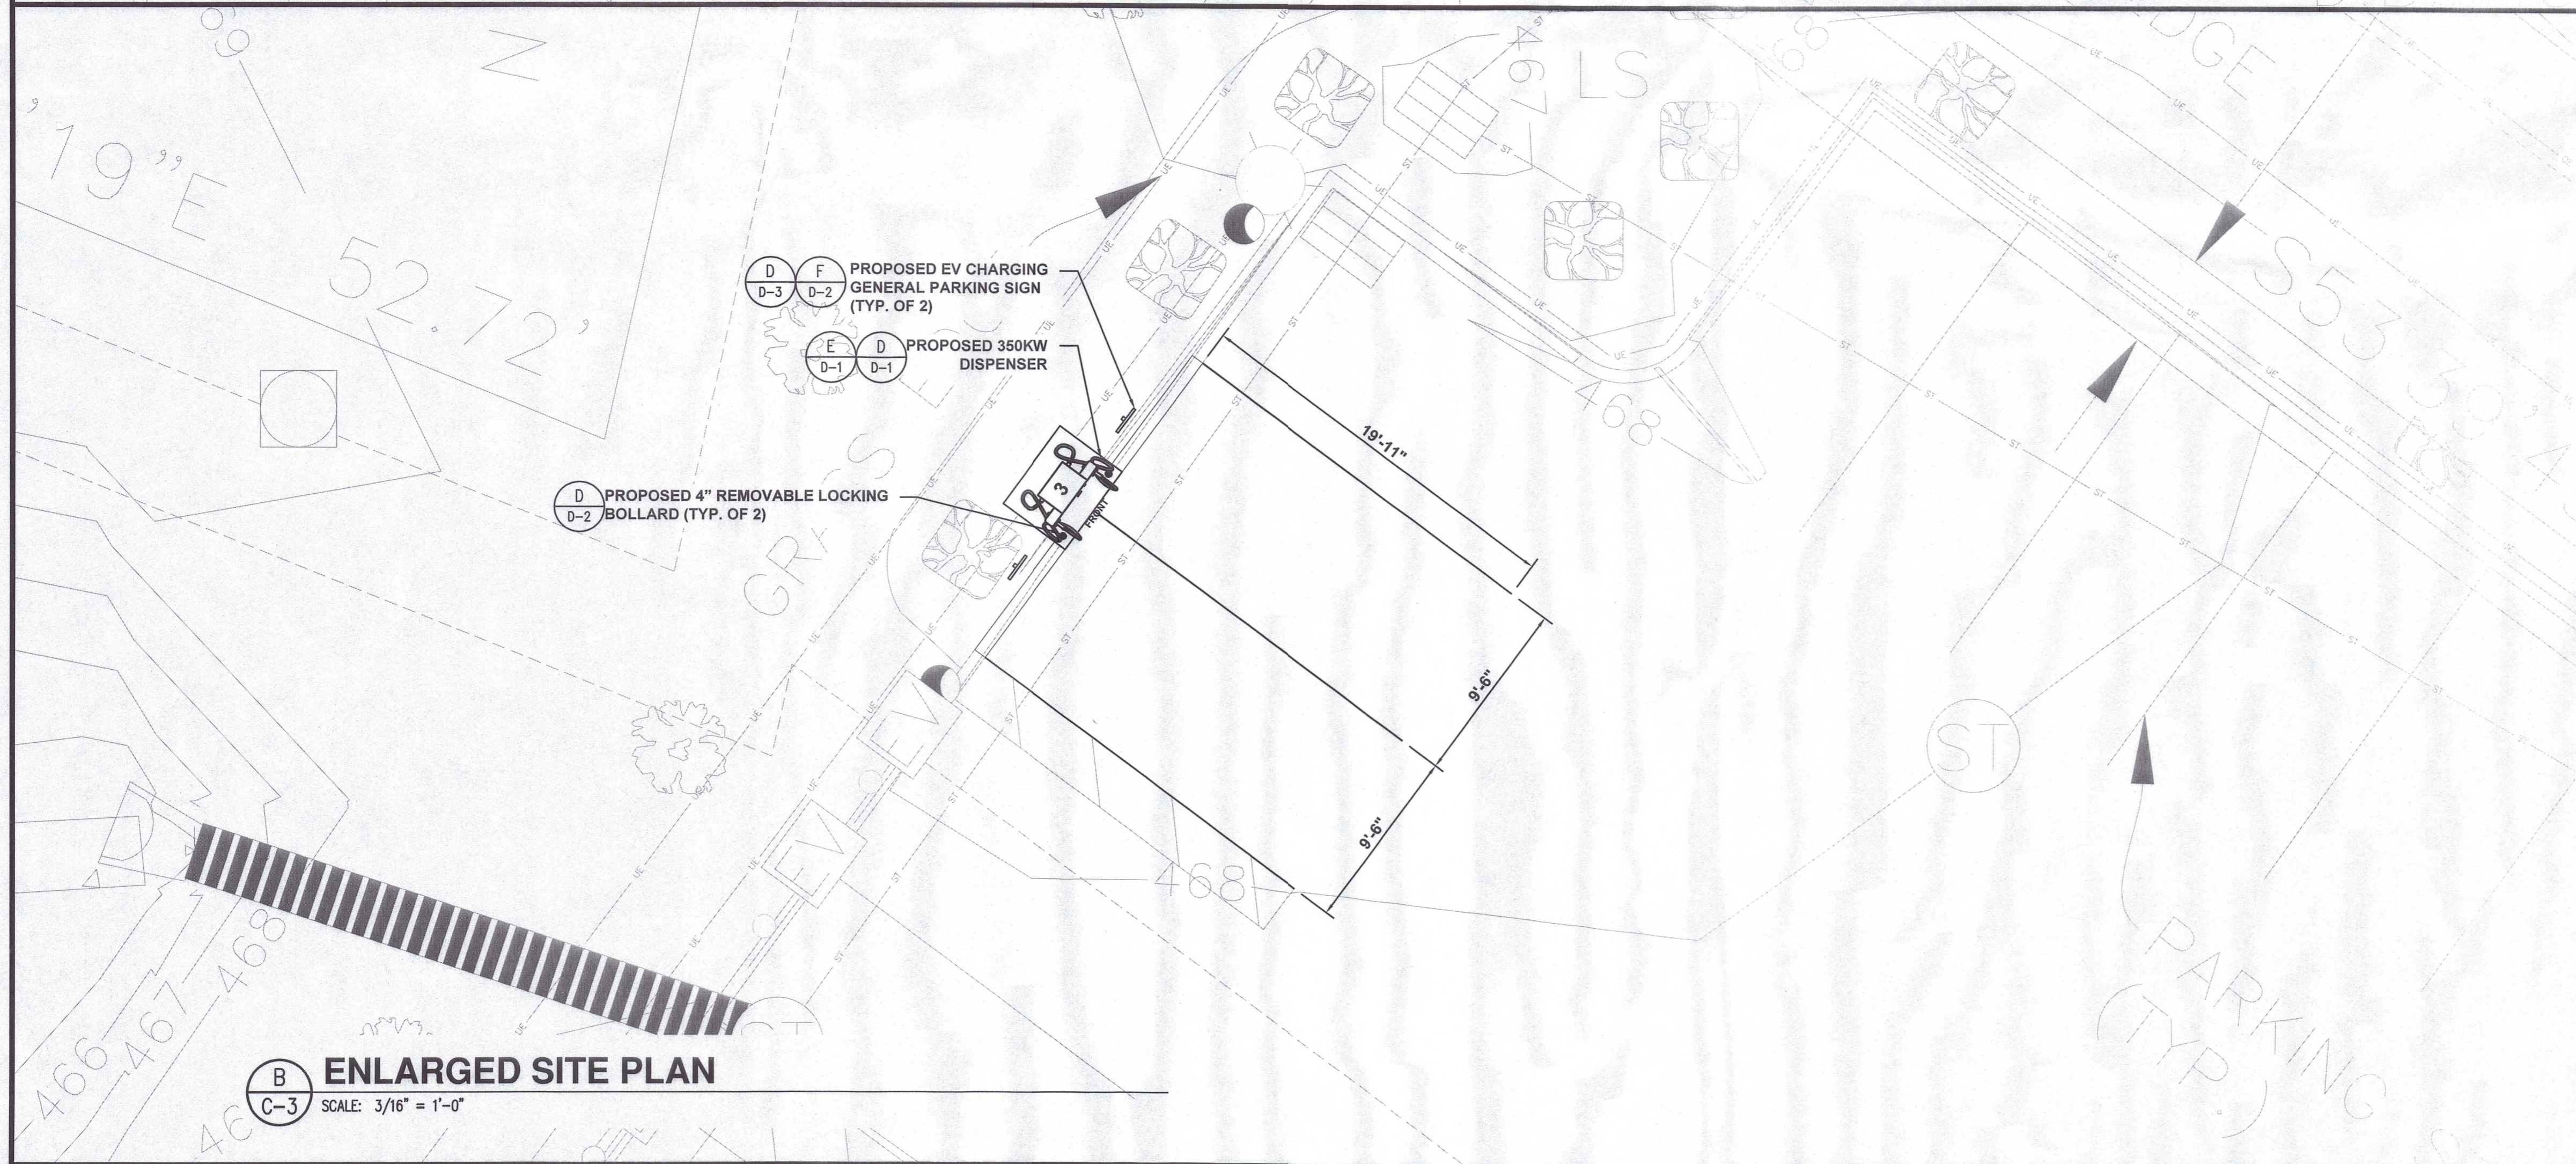

**B**  
C-3  
ENLARGED SITE PLAN  
SCALE: 3/16" = 1'-0"

**PROPOSED DISPENSERS**

CHARGE POST NUMBER	100KW	350KW	CABLE TYPE
1	1		CHAdemo/CCS
2	1		CHAdemo/CCS
3		1	CCS/CCS

**PROJECT STALL COUNT**

EXISTING STALL COUNT	5
PROPOSED STALL COUNT	5
SITE HOST APPROVED STALL COUNT	5

**KEYNOTES**

- SOD PLANTED IN THE FALL MUST ESTABLISH ITS ROOTS BEFORE THE FIRST WINTER FROST. DETERMINE WHEN THE FIRST FROST USUALLY OCCURS, AND PLANT THE SOD NO LATER THAN ONE MONTH BEFORE THE FIRST FROST. IF THE CONSTRUCTION IS FINISHED LATER THAN ONE MONTH BEFORE THE FIRST FROST, USE STRAW UNTIL SOD CAN BE INSTALLED.
- THE CONTRACTOR SHALL RETURN SIDEWALKS, LANDSCAPING, PLANTERS, IRRIGATION SYSTEMS, AND ANY OTHER FACILITIES DISTURBED BY THE WORK TO THE SAME OR BETTER CONDITION THAN EXISTED PRIOR TO THE COMMENCEMENT OF THE WORK.
- CONTRACTOR TO PROVIDE CONDUIT AND WIRE AND BORE UTILITY RUN.



EVgo SERVICES, LLC  
11835 W OLYMPIC BLVD STE 900 E  
LOS ANGELES, CA 90064



Job Name:

**WAWA #0157  
NORTH WALES**

593 DEKALB PIKE - EV  
NORTH WALES, PA 19454

SHEET DESCRIPTION:  
**ENLARGED SITE PLAN**



Project #: P17773  
File:  
Drawn by: KC  
Date(s): 07/25/2022  
2022.07.25 - DD100 PRELIMINARY DESIGN  
2022.08.08 - ISSUED FOR PERMIT

